

REVISIONS	
NO.	DATE
A	2-10-72
B	3-14-72
C	6-12-72
D	7-24-72
E	9-11-72
F	4-12-73
1	10-13-73

DESCRIPTION	
A	REVISIONS TO DRAWING NO. 7101 ADDED OIL PIPE ENCLOSURE AT N.Y.C. SHED #1, L.B. 3
B	REVISIONS TO DRAWING NO. 7101 ADDED OIL PIPE ENCLOSURE AT N.Y.C. SHED #1, L.B. 3
C	REVISIONS TO DRAWING NO. 7101 ADDED OIL PIPE ENCLOSURE AT N.Y.C. SHED #1, L.B. 3
D	REVISIONS TO DRAWING NO. 7101 ADDED OIL PIPE ENCLOSURE AT N.Y.C. SHED #1, L.B. 3
E	REVISIONS TO DRAWING NO. 7101 ADDED OIL PIPE ENCLOSURE AT N.Y.C. SHED #1, L.B. 3
F	REVISIONS TO DRAWING NO. 7101 ADDED OIL PIPE ENCLOSURE AT N.Y.C. SHED #1, L.B. 3
1	REVISIONS TO DRAWING NO. 7101 ADDED OIL PIPE ENCLOSURE AT N.Y.C. SHED #1, L.B. 3

**BANKERS TRUST
PLAZA**

**A FISHER BROTHERS
PROJECT**

GREENWICH AND LIBERTY ST. N.Y. N.Y.

SHREVE LAMB & HARMON ASSOCIATES PC
ARCHITECTS

475 PARK AVENUE SOUTH N.Y. N.Y. 10016

PETERSON AND BRICKBAUER
ASSOCIATED ARCHITECTS

919 THIRD AVENUE N.Y. N.Y. 10022

THE OFFICE OF JAMES RUDERMAN
STRUCTURAL ENGINEERS

515 MADISON AVENUE N.Y. N.Y. 10022

J.A. ROSS, BAUM & BOLL'S
MECHANICAL ENGINEERS

345 PARK AVENUE N.Y. N.Y. 10022

4TH FLOOR PLAN, COMPOSITE


(4TH FL. TENANT)

PROJECT NUMBER
7101

DRAWING NUMBER
A 36

DATE JAN 3, 1972

SCALE 1/8" = 1'-0"

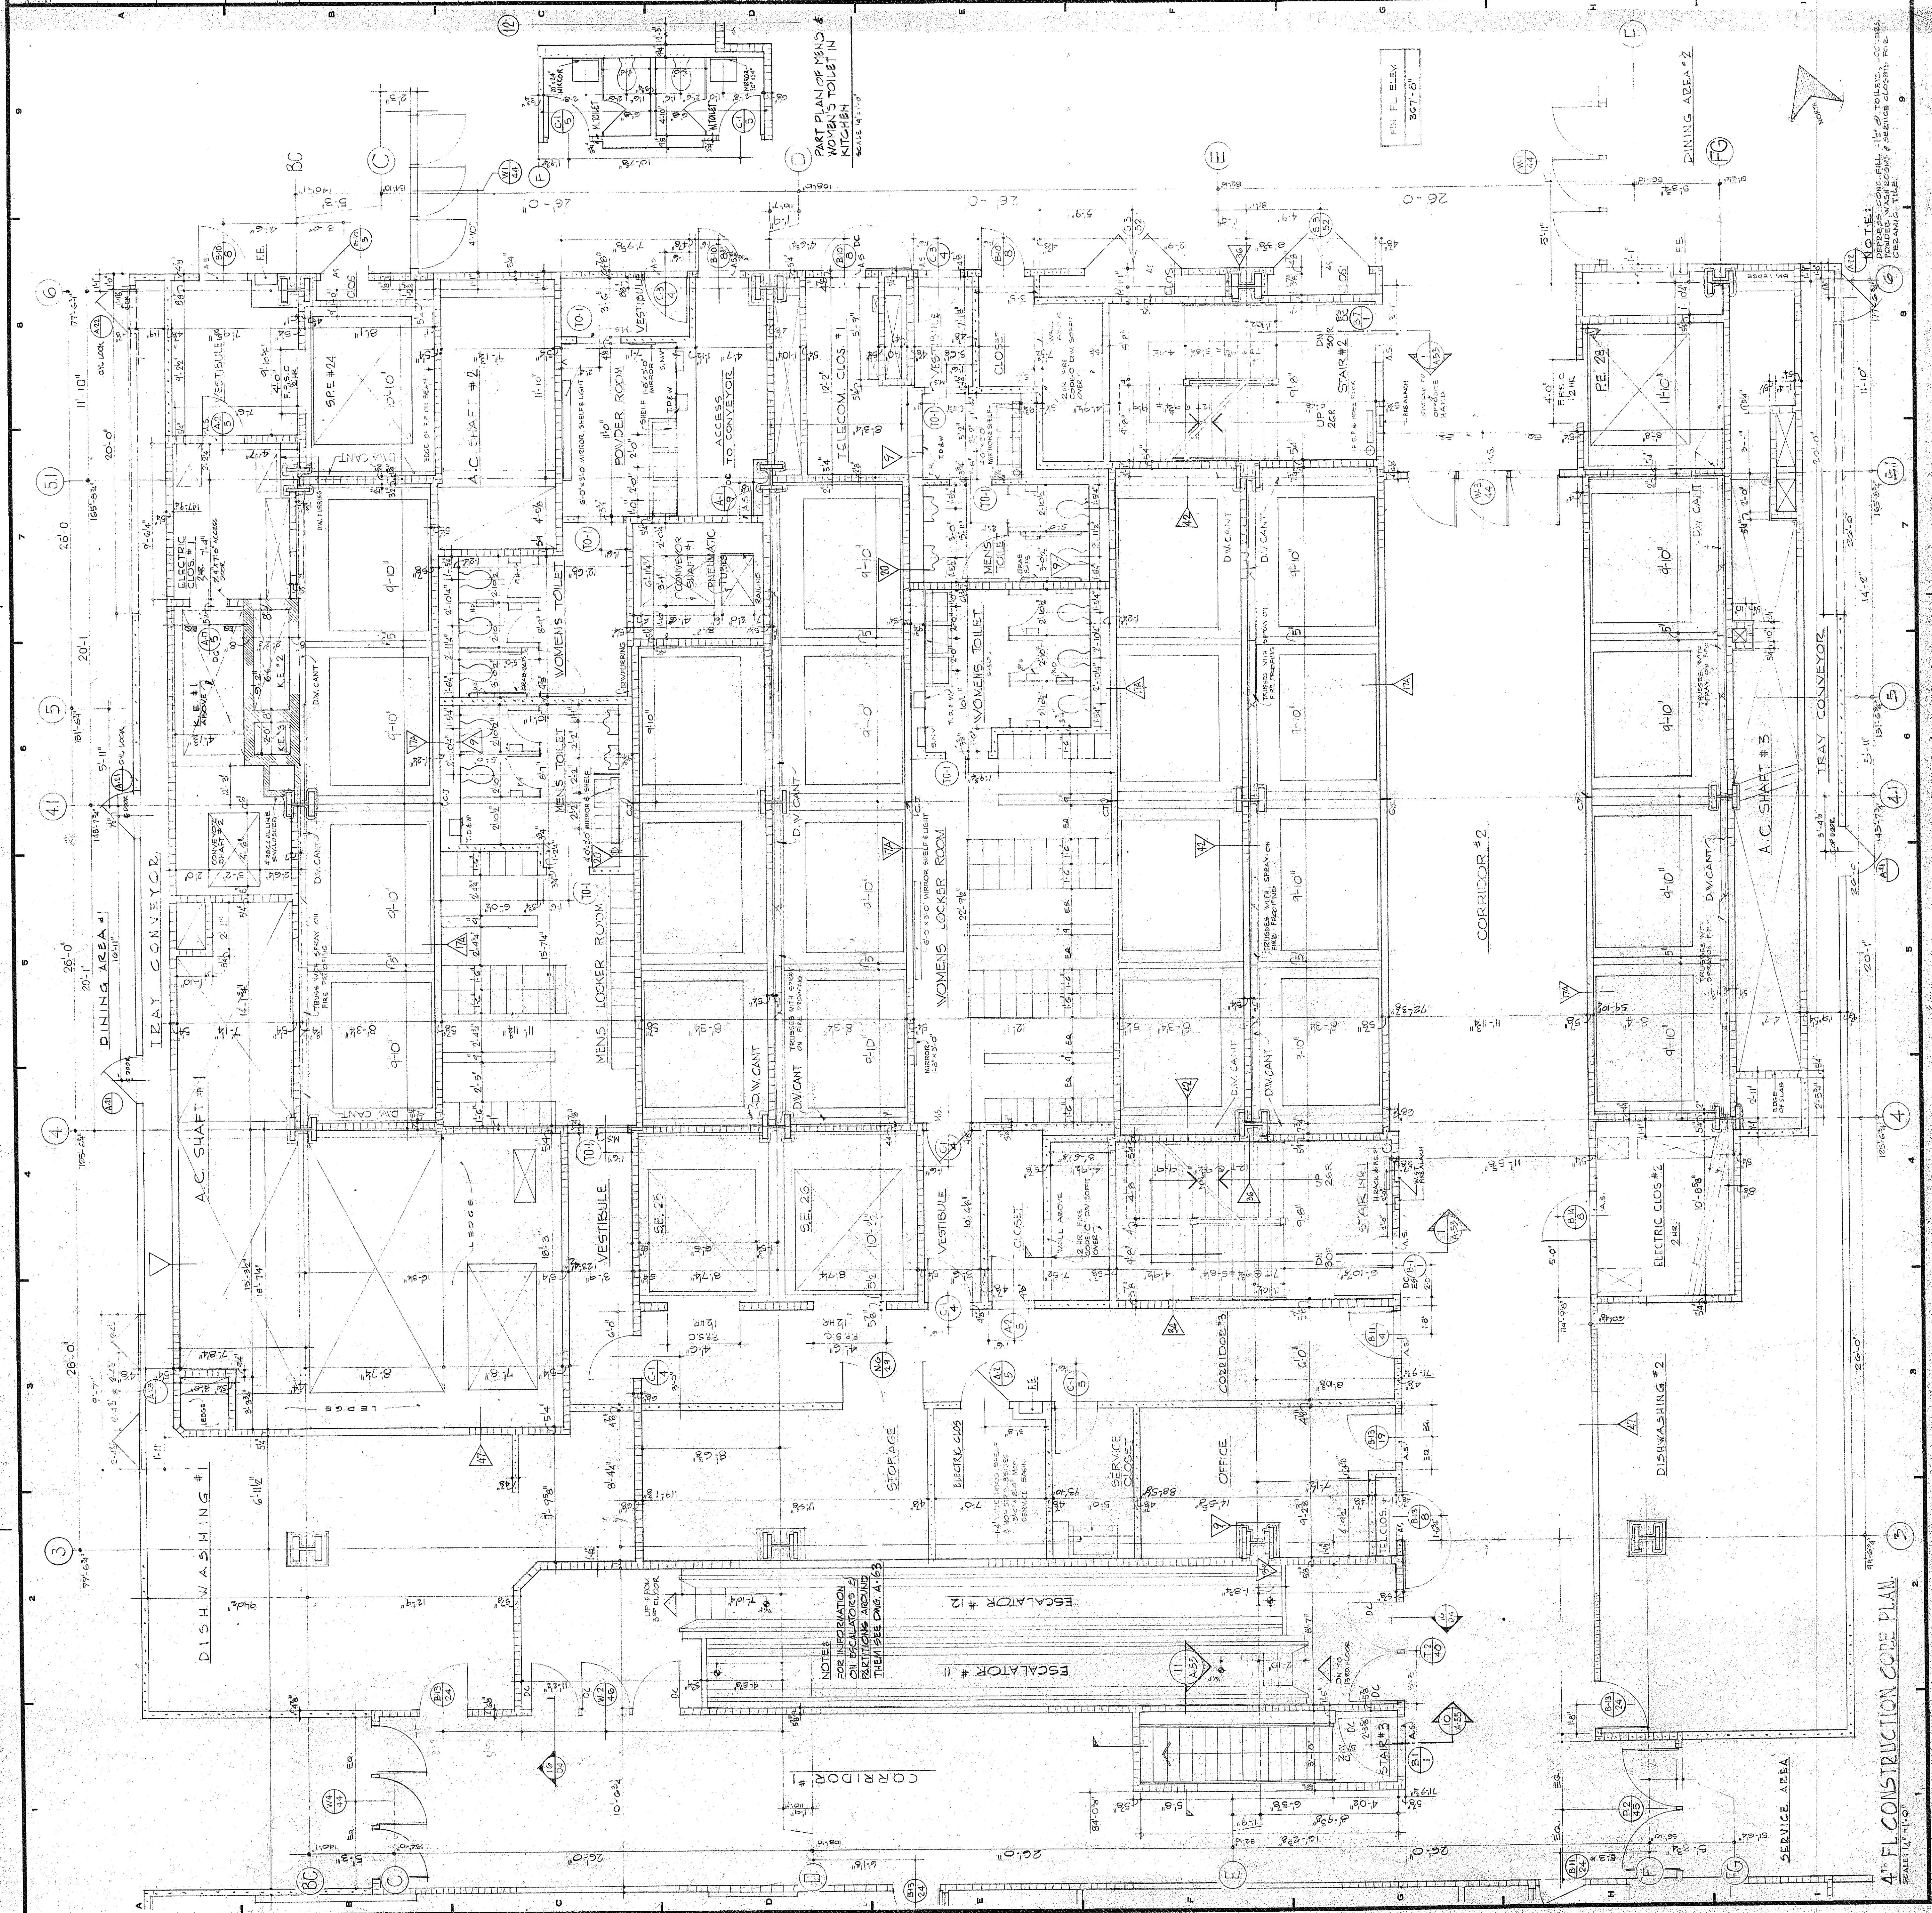

4TH FL CONSTRUCTION CODE PLAN

SCALE 1/8" = 1'-0"