
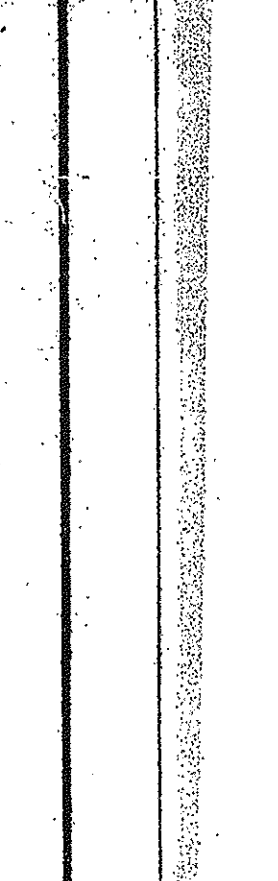
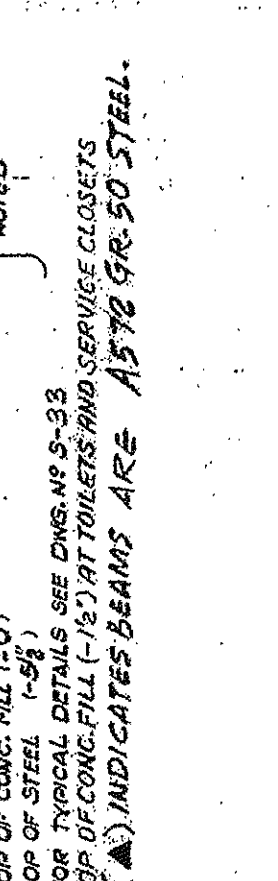
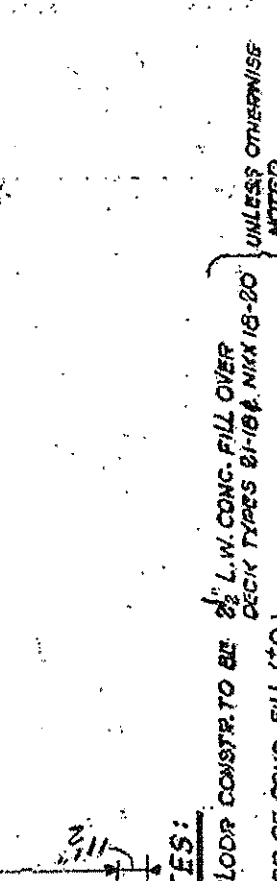
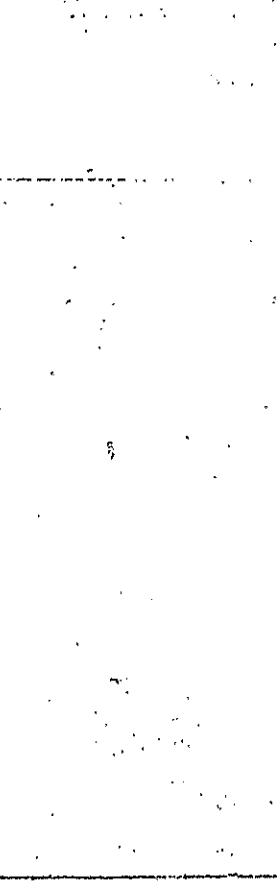
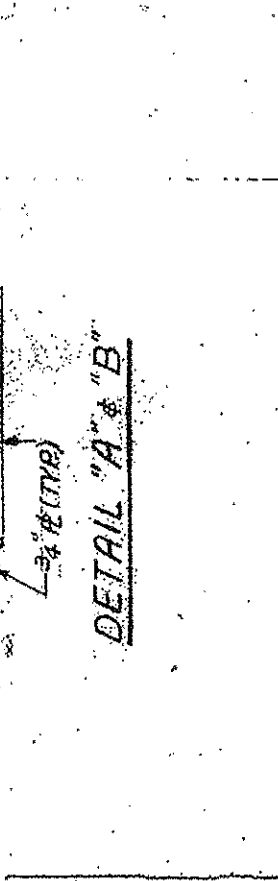
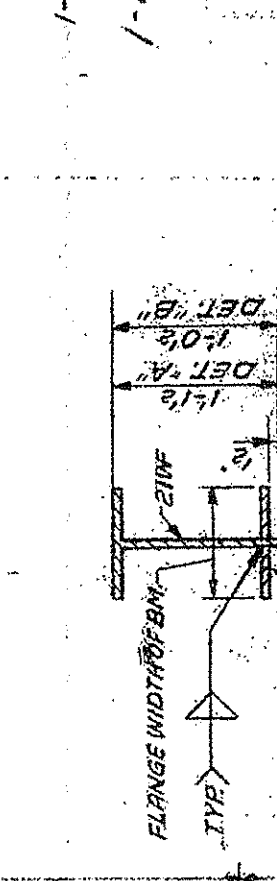
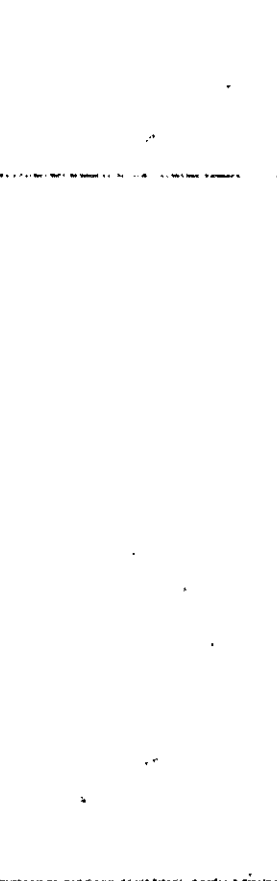
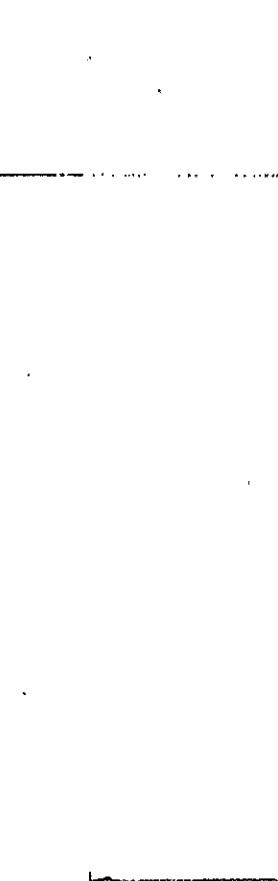
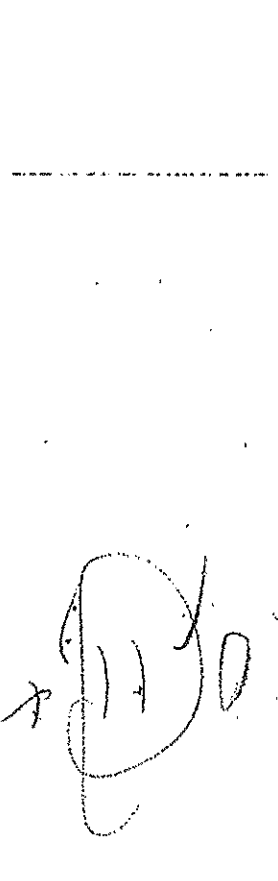
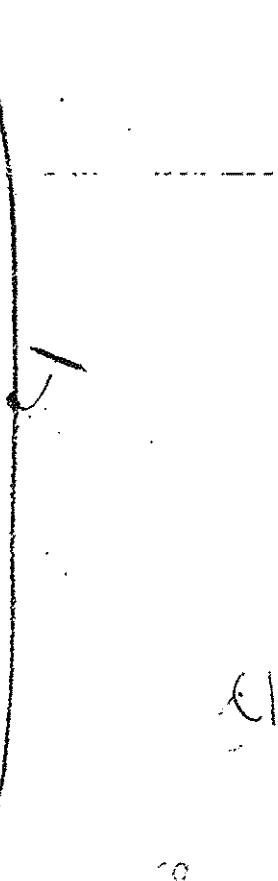
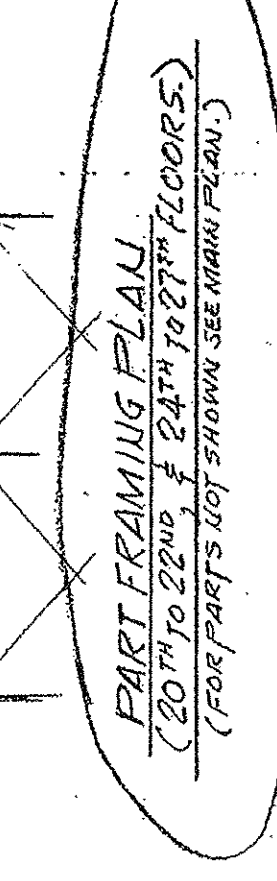
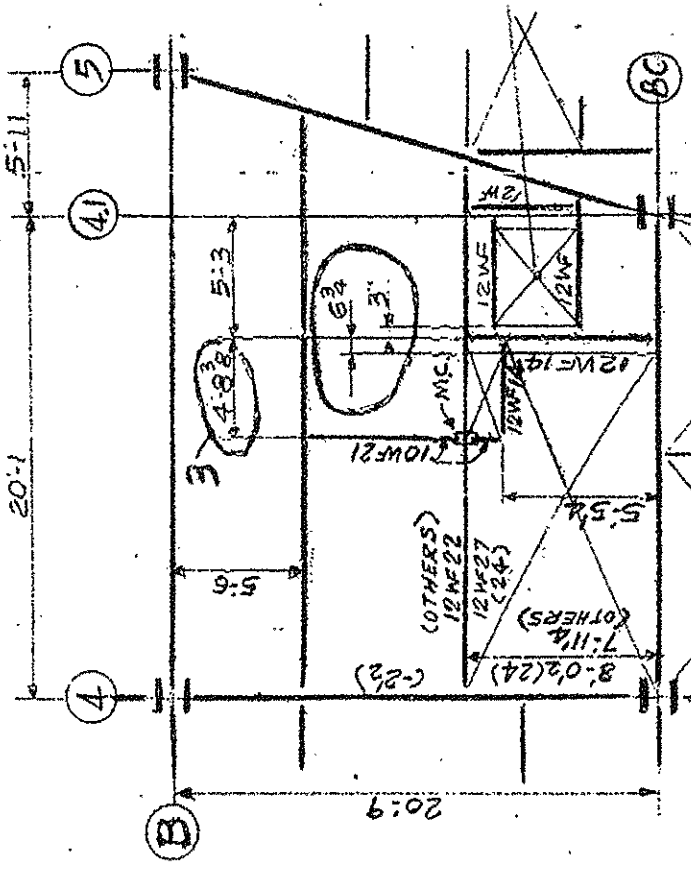


REVISIONS		
NO.	DATE	DESCRIPTION
1	3-7-72	REVISED MECHANICAL PLAN
2	3-15-72	CHANGED MECHANICAL PLAN
3	4-6-72	CHANGED MECHANICAL PLAN
4	7-10-72	CHANGED MECHANICAL PLAN
5	8-4-72	CHANGED MECHANICAL PLAN
6	1-8-73	CHANGED MECHANICAL PLAN

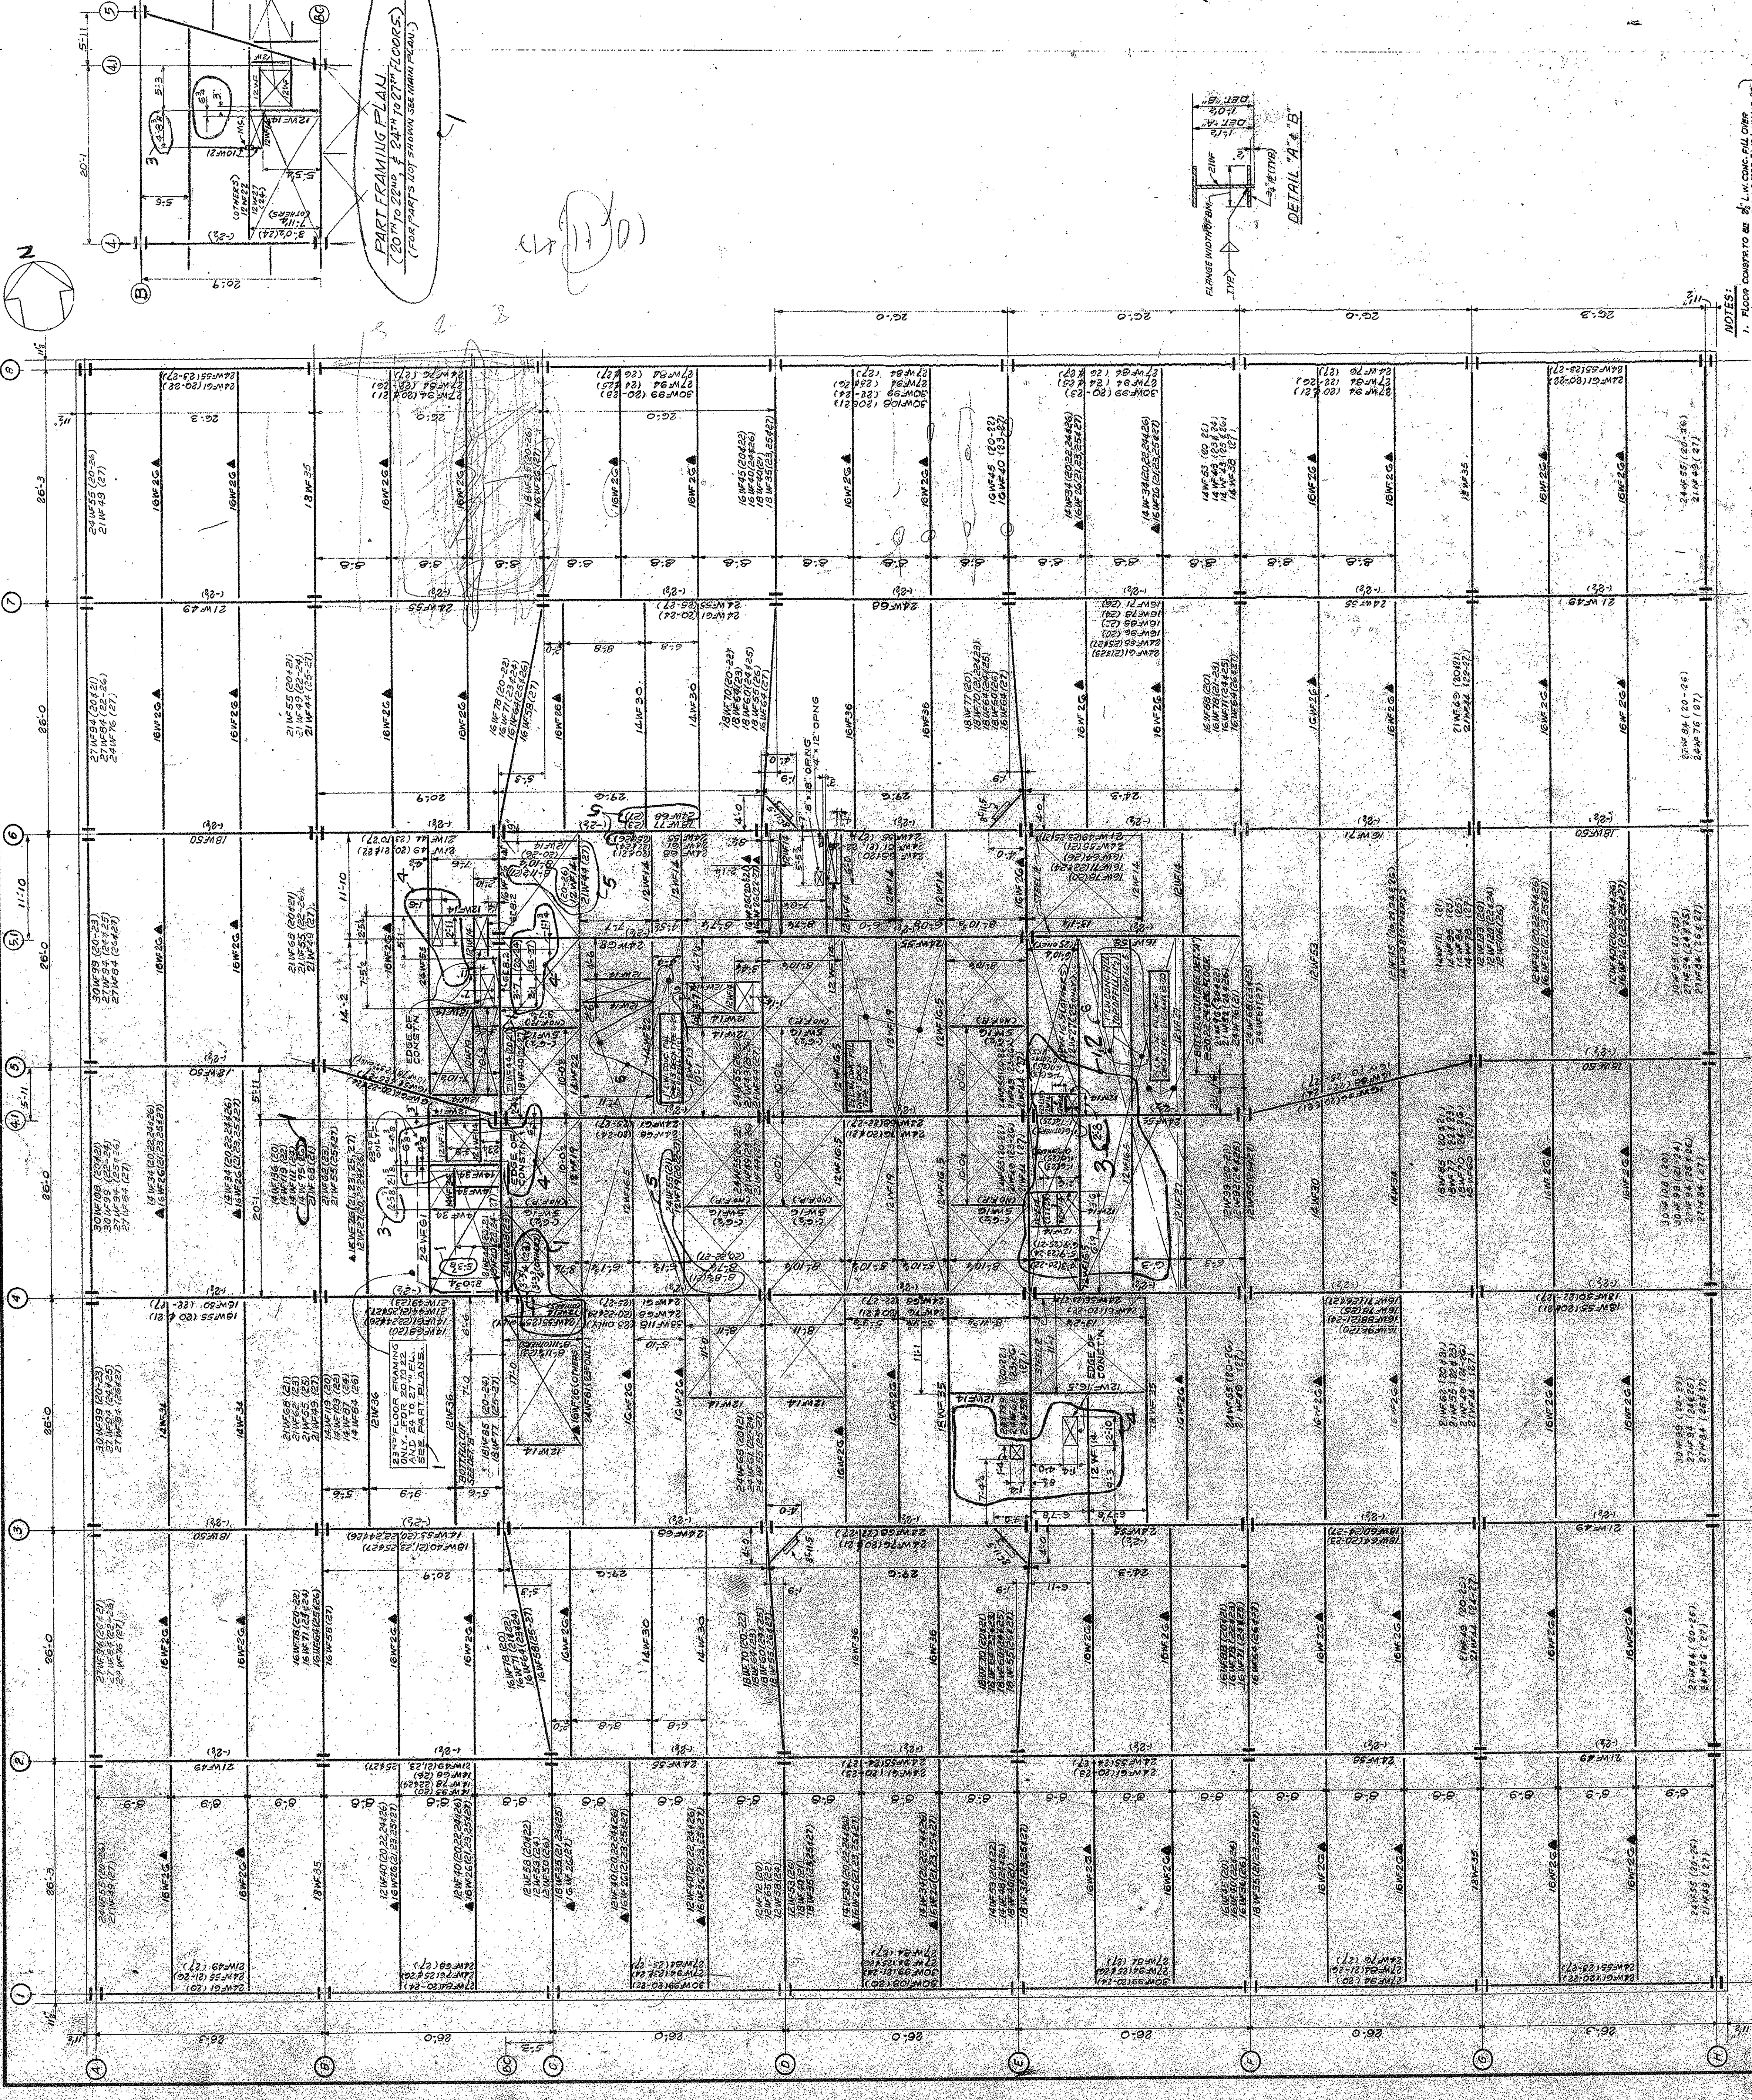

**BANKERS TRUST
PLAZA**

**A FISHER BROTHERS
PROJECT**

GREENWICH AND LIBERTY ST. N. Y. N. Y.

SHREVE, LAMB & HARMON ASSOCIATES PC
ARCHITECTS
475 PARK AVENUE SOUTH N. Y. N. Y. 10016

PETERSON AND BRICKBAUER
ASSOCIATED ARCHITECTS
919 THIRD AVENUE N. Y. N. Y. 10022

THE OFFICE OF JAMES RUDERMAN
STRUCTURAL ENGINEERS
315 MADISON AVENUE N. Y. N. Y. 10017

J. A. ROSS, BAUM & BOLLER
MECHANICAL ENGINEERS
345 PARK AVENUE N. Y. N. Y. 10022

20th to 21st Floor
FRAMING PLAN

PROJECT NUMBER
7101

DRAWING NUMBER
S 21

DATE
1-8-73

SCALE
1/8" = 1'-0"

NOTES:

1. FLOOR COMPLETION TO BE 11'-0" TO 11'-6" (SEE 1-24-72 REMINDER OF PLAN RELEASED FOR ORDERING & DETAILING)
2. TOP OF DECK SHALL BE 11'-0" TO 11'-6" (SEE 1-24-72 REMINDER OF PLAN RELEASED FOR ORDERING & DETAILING)
3. ALL DIMENSIONS ARE IN FEET AND INCHES (SEE 1-24-72 REMINDER OF PLAN RELEASED FOR ORDERING & DETAILING)
4. FOR TYPICAL DETAILS SEE DRAWING S-33
5. FOR TYPICAL DETAILS SEE DRAWING S-34
6. (A) INDICATES BEAMS ARE 15" X 24" S.F. STEEL